


Check all dimensions and site conditions prior to commencement of any work, the purchase or ordering of any materials, fittings, plant, services or equipment and the preparation of shop drawings and/or the fabrication of any components.  
 Do not scale drawings - refer to figured dimensions only. Any discrepancies shall immediately be referred to the architect for clarification.  
 All drawings may not be reproduced or distributed without prior permission from the architect.

**NOT FOR CONSTRUCTION**

**ROOF FINISHES CODE:**  
 RS-01 LYSAGHT KLIP-LOK 700 COLORBOND ROOFING COLOUR: GULL GREY  
 GT-01 STAINLESS STEEL EAVES GUTTER  
 DP-01 STAINLESS STEEL CIRCULAR DOWNPIPE  
 RV-01 PROPRIETARY ROOF VENTILATOR, COLORBOND

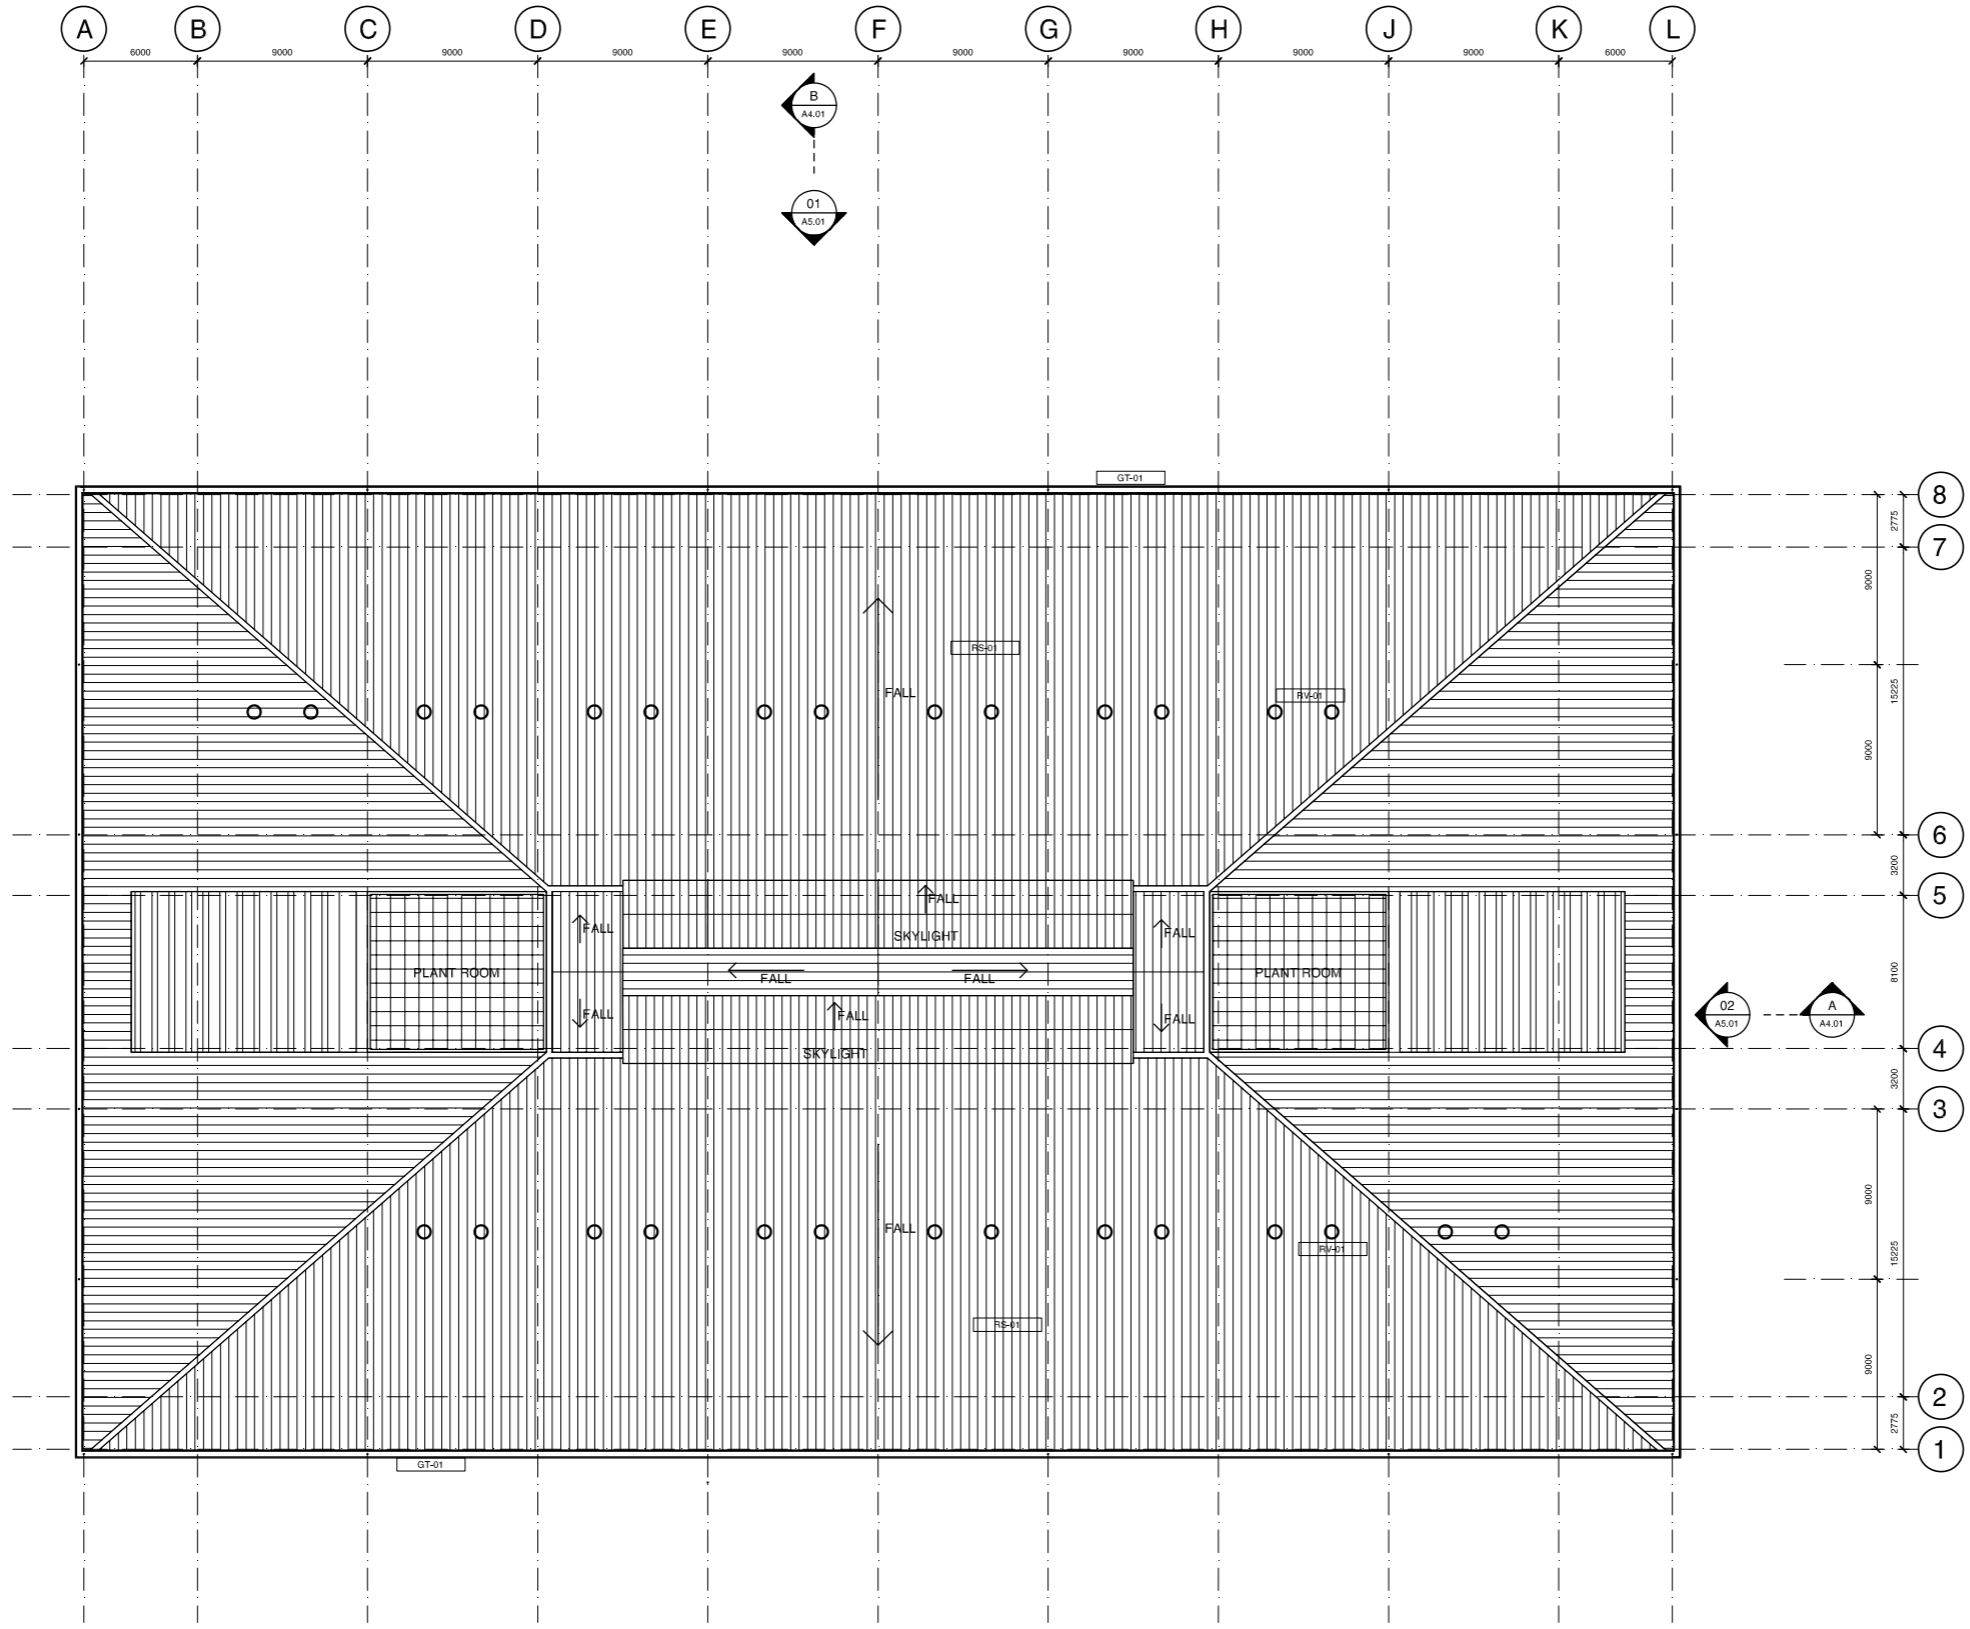

01 Roof Plan 1:200

Rev.	Date	Description	Initial	Checked
A	30/06/2008	PART 3A APPLICATION	MD	
P3	20/06/2008	PRELIMINARY D.A. ISSUE	MD	
P2	19/06/2008	PRELIMINARY CONSULTANT ISSUE	MD	
P1	30/05/2008	PRELIMINARY CONSULTANT ISSUE	MD	

**Sydney Water  
Potts Hill**

**Roof Plan**

Scale: 1:200 @ A1 & 1:400 @ A3  
 Drawn: PL  
 Project No.: S10955  
 Status: Development Application  
 Plot Date: 1/7/2008 2:20:16 PM  
 Plot File: O:\10900-10999\S10955\_SWA\_POTTS\_HILL\00\_MAIN\CAD\PLANS\DA\AR-DA-2.03.DWG

Drawing No. **AR DA 2.03 A**

disc stage no. revision  
 Sydney 1/263 Liverpool Street East Sydney NSW 2010 Australia  
 T 02 9380 7288 F 02 9380 7280  
 email syd@batesmart.com.au http://www.batesmart.com.au  
 Melbourne 1 Nicholson Street Melbourne VIC 3000 Australia  
 T 03 8664 6200 F 03 8664 6300  
 email mel@batesmart.com.au http://www.batesmart.com.au

Bates Smart Pty Ltd ABN 70 004 999 400

